




HVAC PLAN

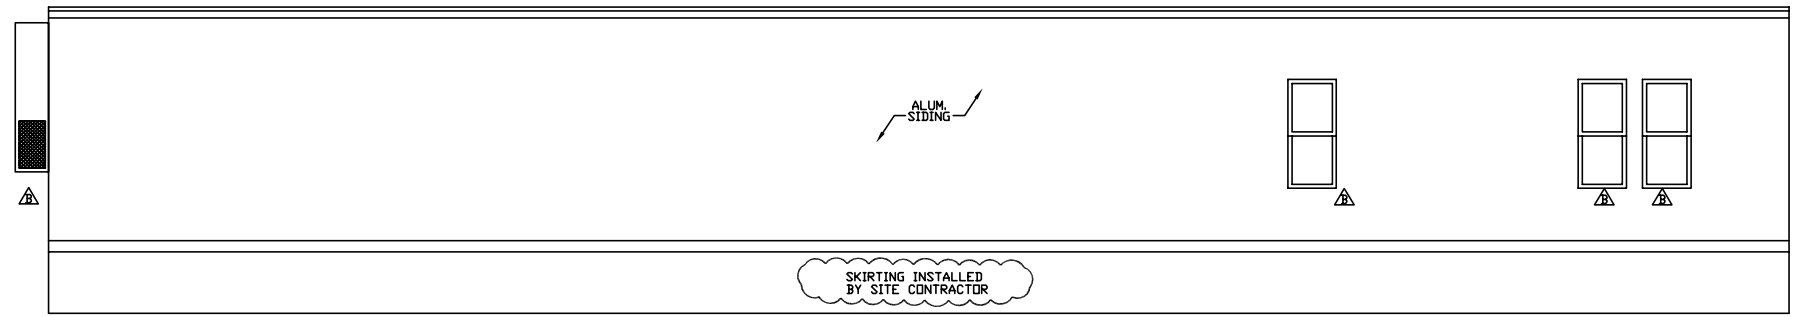


CURBSIDE ELEVATION
SCALE: 1/4"=1'-0"

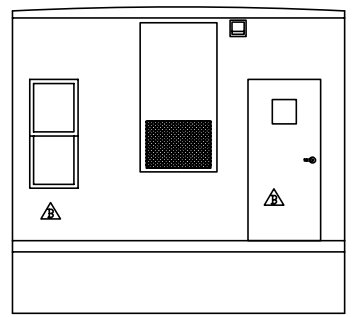

REAR END ELEVATION
SCALE: 1/4"=1'-0"

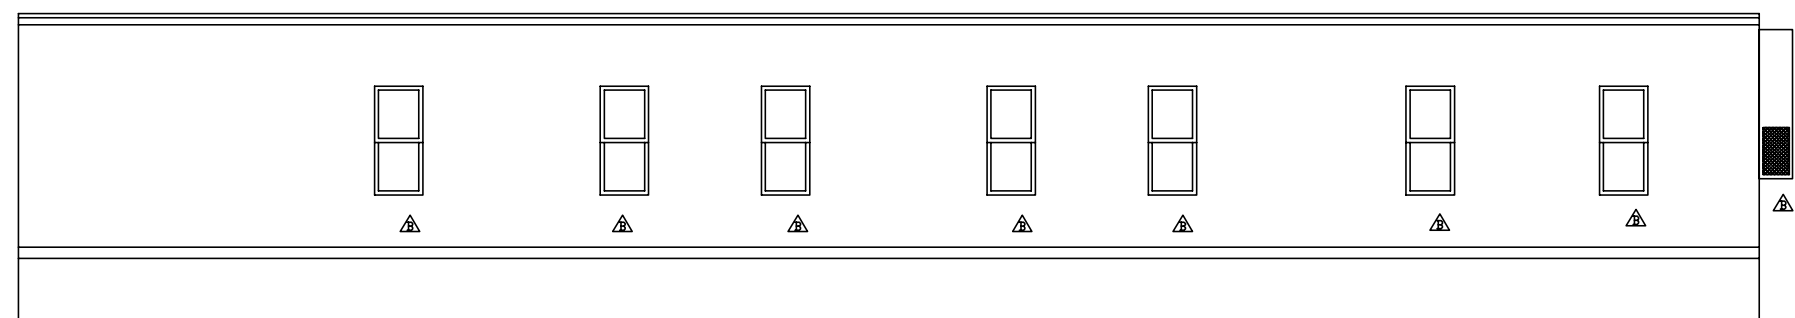

ROADSIDE ELEVATION
SCALE: 1/4"=1'-0"

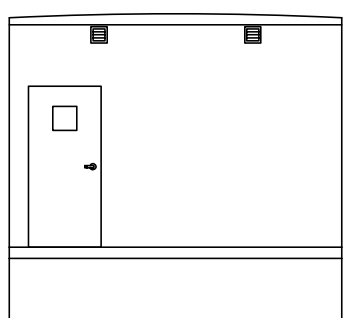

HITCH END ELEVATION
SCALE: 1/4"=1'-0"

SYMBOL	DESCRIPTION
	120 V., 15 AMP, TOGGLE TYPE SWITCH
	w/INSULATED GROUND, 48" AFF
	DUPLEX RECEPT V/INSULATED GROUND 20 AMP 18" AFF
	WATER HEATER
	WATER INLET LOCATION
	MAIN DRAIN LOCATION
	PLUMBING VENT THRU ROOF
	THERMOSTAT, 48" AFF
	CEILING EXHAUST FAN (CFM AS NOTED)
	GABLE ATTIC POWER VENT
	8 X 8 GABLE ATTIC VENT
	RETURN AIR GRILLE DN 3"
	8 X 8 CEILING RETURN AIR DIFFUSER
	8 X 8 CEILING SUPPLY AIR DIFFUSER
	DOUBLE FACE EXIT SIGN 84" AFF
	SINGLE FACE EXIT SIGN 87" AFF
	SINGLE GANG J-BOX FOR PHONE/COMP., 18" AFF
	TOGGLE TYPE SWITCH 48" AFF
	DUPLEX RECEPT 18" AFF (UNLESS NOTED)
	WP DUPLEX GFI RECEPTACLE 6" AFF
	DUPLEX RECEPTACLE 18" AFF
	DUPLEX GFI RECEPT 48" AFF
	HEAT TAPE RECEPTACLE (BELOW FLOOR), 36" FROM EDGE OF BUILDING
	DUAL HEAD EMERGENCY LIGHT 87" AFF
	EXTERIOR INCANDESCENT LIGHT 84" AFF
	INCANDESCENT LIGHT 78" AFF
	DIFFUSED SURFACE MOUNTED FLUOR. LIGHT
	LOAD CENTER

DRAWING LEGEND

REV	DESCRIPTION	DATE	BY
1	CHANGE ORDER #1	10/18/05	LB
2	CHANGE ORDER #2	11/7/05	LB



TRIUMPH LEASING
 PROJECT NAME: BRIDGEPORT HEALTH CENTER
 PLANT: EPHRATA
 ADDRESS: 502 ALEXANDER DRIVE
 EPHRATA, PA. 17522

MODEL: F-1476
 DATE: 10/14/05
 DRAWN BY: LB
 DRAWING SCALE:
 QUOTE NO.: T-9642R
 SERIAL NO.: E-51024133
 DRAWING NUMBER: AH1